


6b

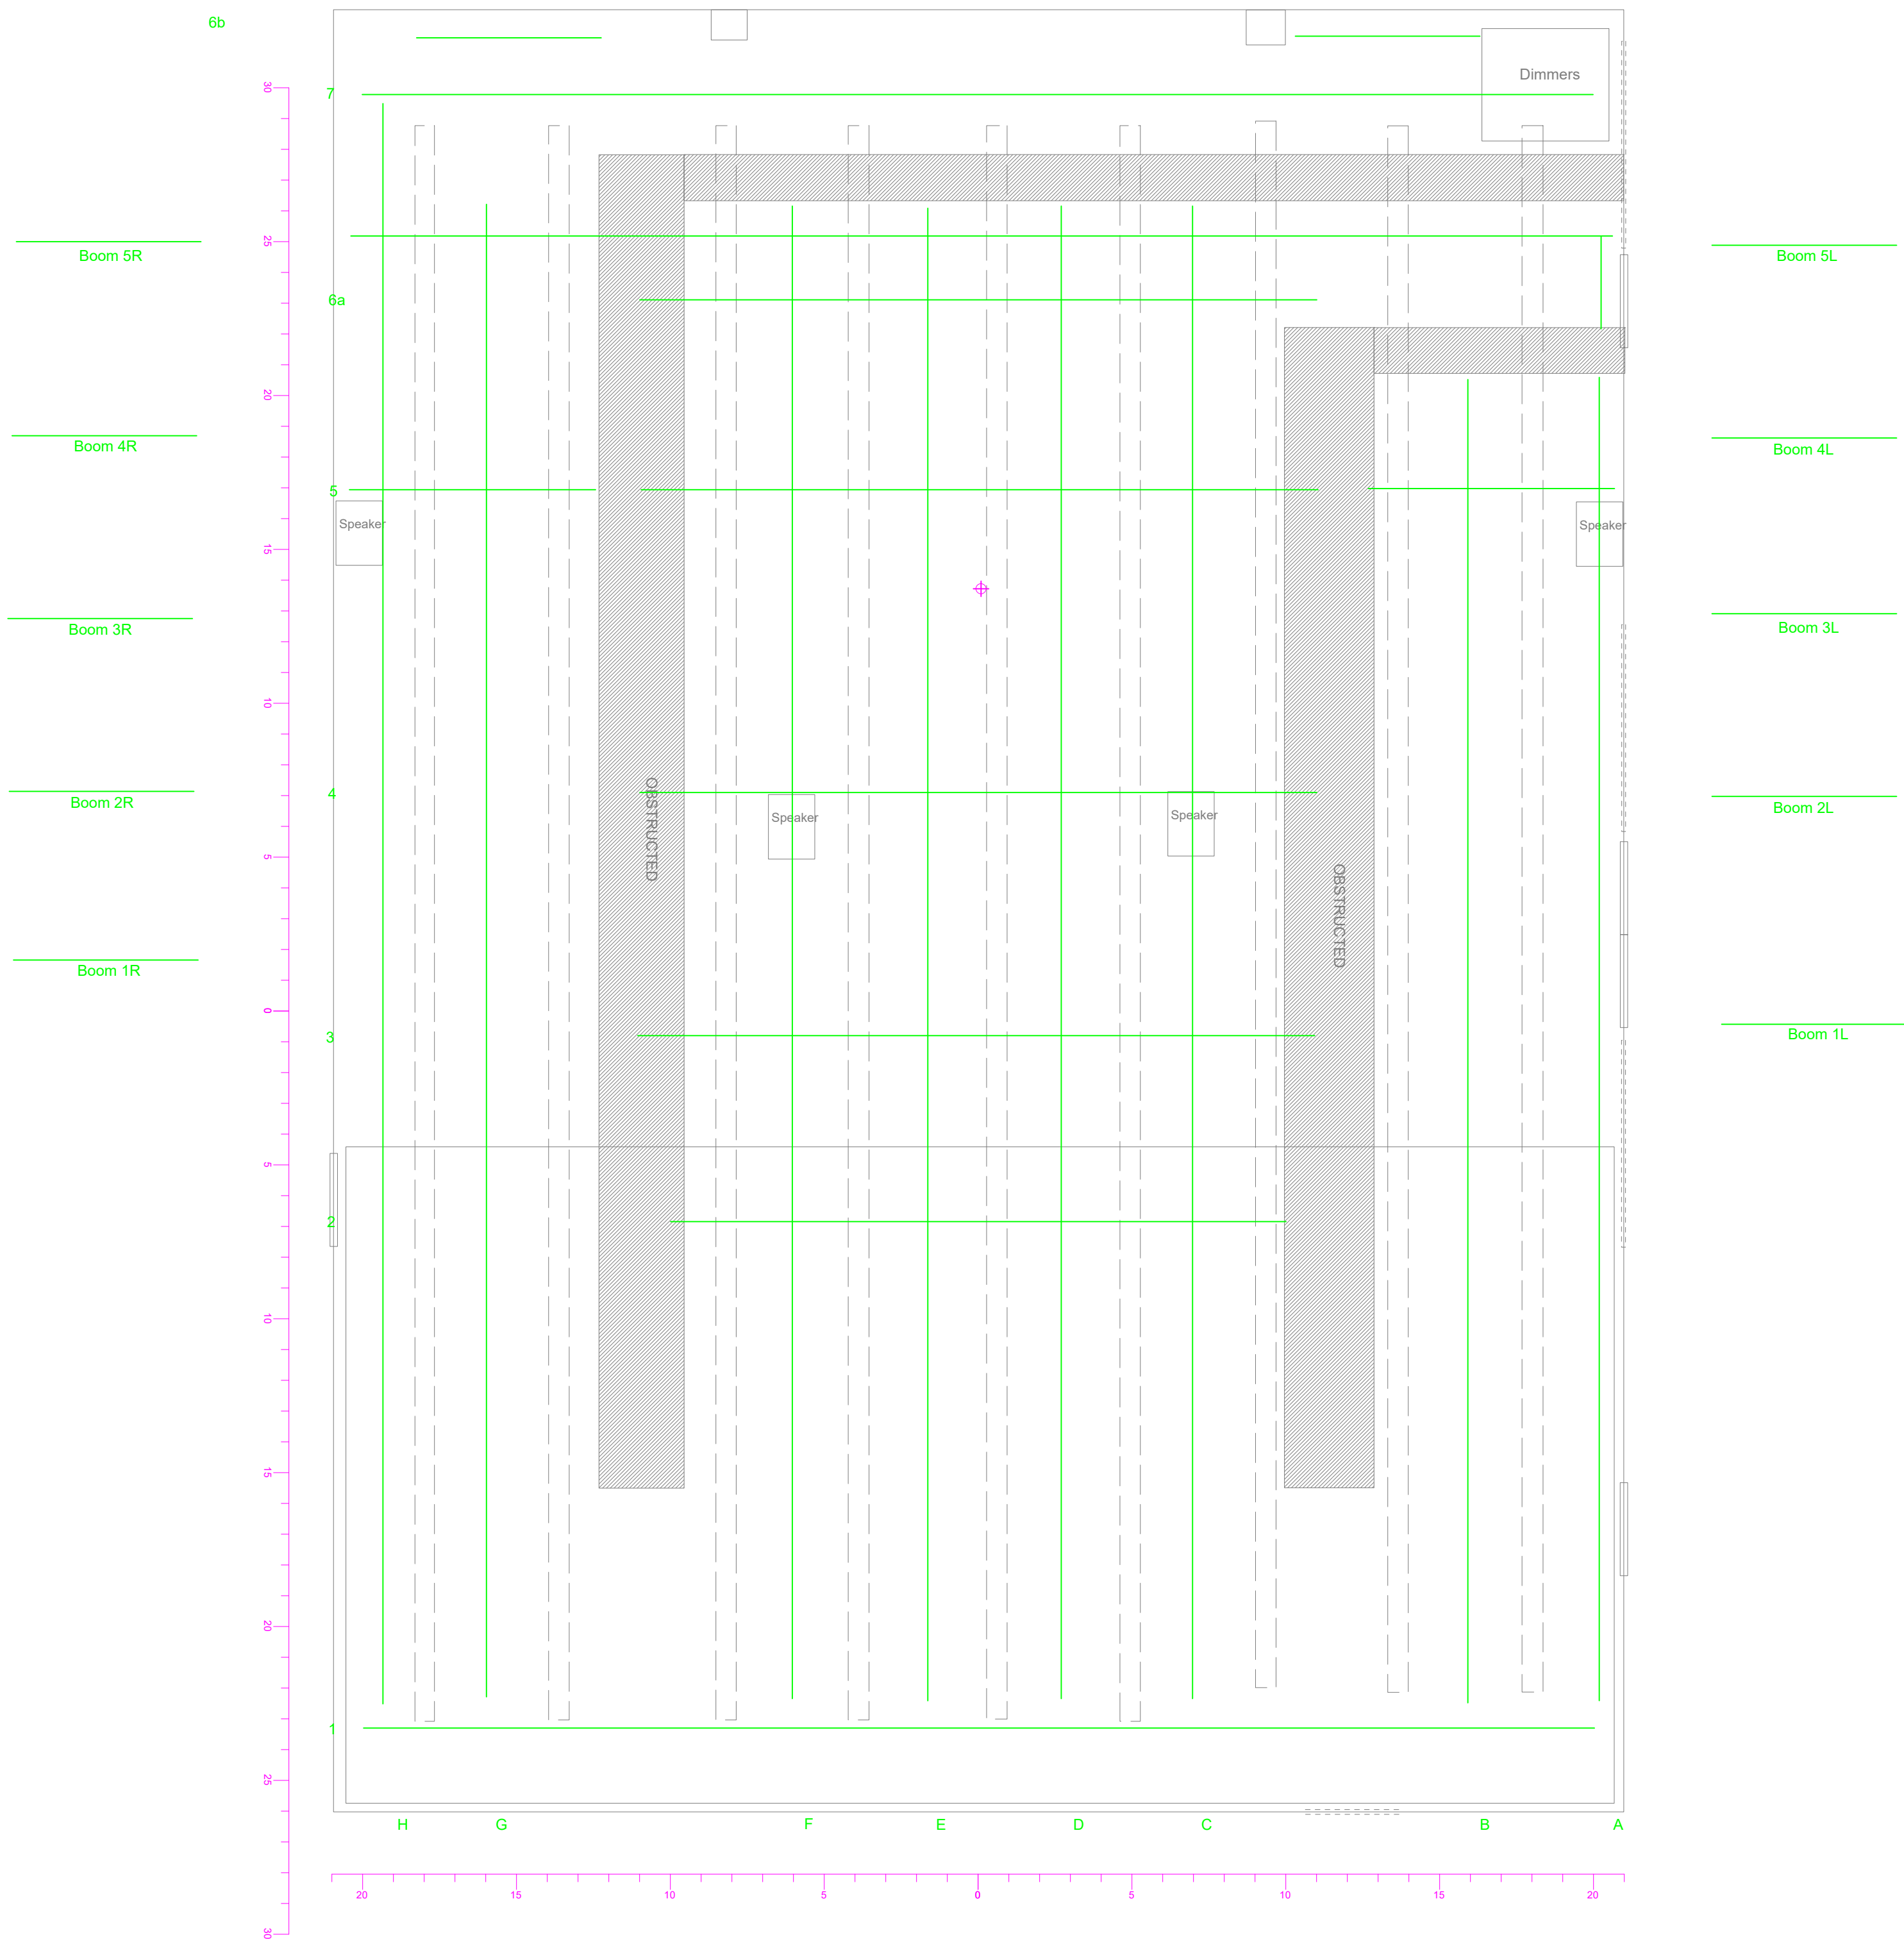

Legend	
Symbol	Type

NOTES:
 12 spare 1.2k dimmers for specials (96 total)
 Please consult venue for available lighting fixtures
 TwoFers are according to Channel Numbers
 Side Hang Booms
 All Legs hang 5' out from wall; can be adjusted up to 10' from wall
 All fixtures can have colours changed for your show.
 The Booms can have colours changed during the performance
 Please provide gobos as follows:
 Altman Zooms: "B" size only
 ETC Source 4's: "A" or "B" size - "A" size preferred
 Consult venue for number of available holders in each size

Rachel Browne Theatre - 2020	
Lighting Plan	
Masking and Floor	Sheet: 1 of 10
	Scale 1/4 in = 1 ft
Drawn by: Hugh Conacher	Date: 2020-04-07